



1 SITE LIGHTING PLAN
1" = 20'-0"

SITE LIGHTING FIXTURE SCHEDULE					
ALL FIXTURES SHALL BE PURCHASED THROUGH THE NATIONAL ACCOUNT VENDOR					
REFER TO ELECTRICAL SPECIFICATIONS FOR ADDITIONAL REQUIREMENTS WHICH MAY NOT NECESSARILY BE REFLECTED IN CATALOG NUMBER AND/OR DESCRIPTION IN THIS SCHEDULE.					
MARK	DESCRIPTION	MOUNTING	VOLT	LAMPS	REMARKS
T3B-BC	(1) SPAULDING #CL1-60L-4K-3-BC WITH 25'-0" POLE SSS-25-40-7-A2-GR, ARM MOUNT SINGLE LUMINAIRE. POLE BASE 3'-0".	POLE MOUNTED RE: 4/ES1	120	60 LED'S	PROVIDE GREY FINISH. PROVIDE POLE WIND RATING FOR AREA INSTALLED.
T4B	(1) SPAULDING #CL1-60L-4K-4 WITH 25'-0" POLE SSS-25-40-7-A2-GR, ARM MOUNT SINGLE LUMINAIRE. POLE BASE 3'-0".	POLE MOUNTED RE: 4/ES1	120	60 LED'S	PROVIDE GREY FINISH. PROVIDE POLE WIND RATING FOR AREA INSTALLED.
T4B-BC	(1) SPAULDING #CL1-60L-4K-4-BC WITH 25'-0" POLE SSS-25-40-7-A2-GR, ARM MOUNT SINGLE LUMINAIRE. POLE BASE 3'-0".	POLE MOUNTED RE: 4/ES1	120	60 LED'S	PROVIDE GREY FINISH. PROVIDE POLE WIND RATING FOR AREA INSTALLED.

- NOTES
1. VERIFY ALL OVERHEAD AND UNDERGROUND UTILITIES PRIOR TO INSTALLATION OF LIGHT POLE BASES AND CONDUIT. REFER TO DRAWING E2 / E2MC FOR ALL BUILDING MOUNTED EXTERIOR LIGHTING FIXTURES.

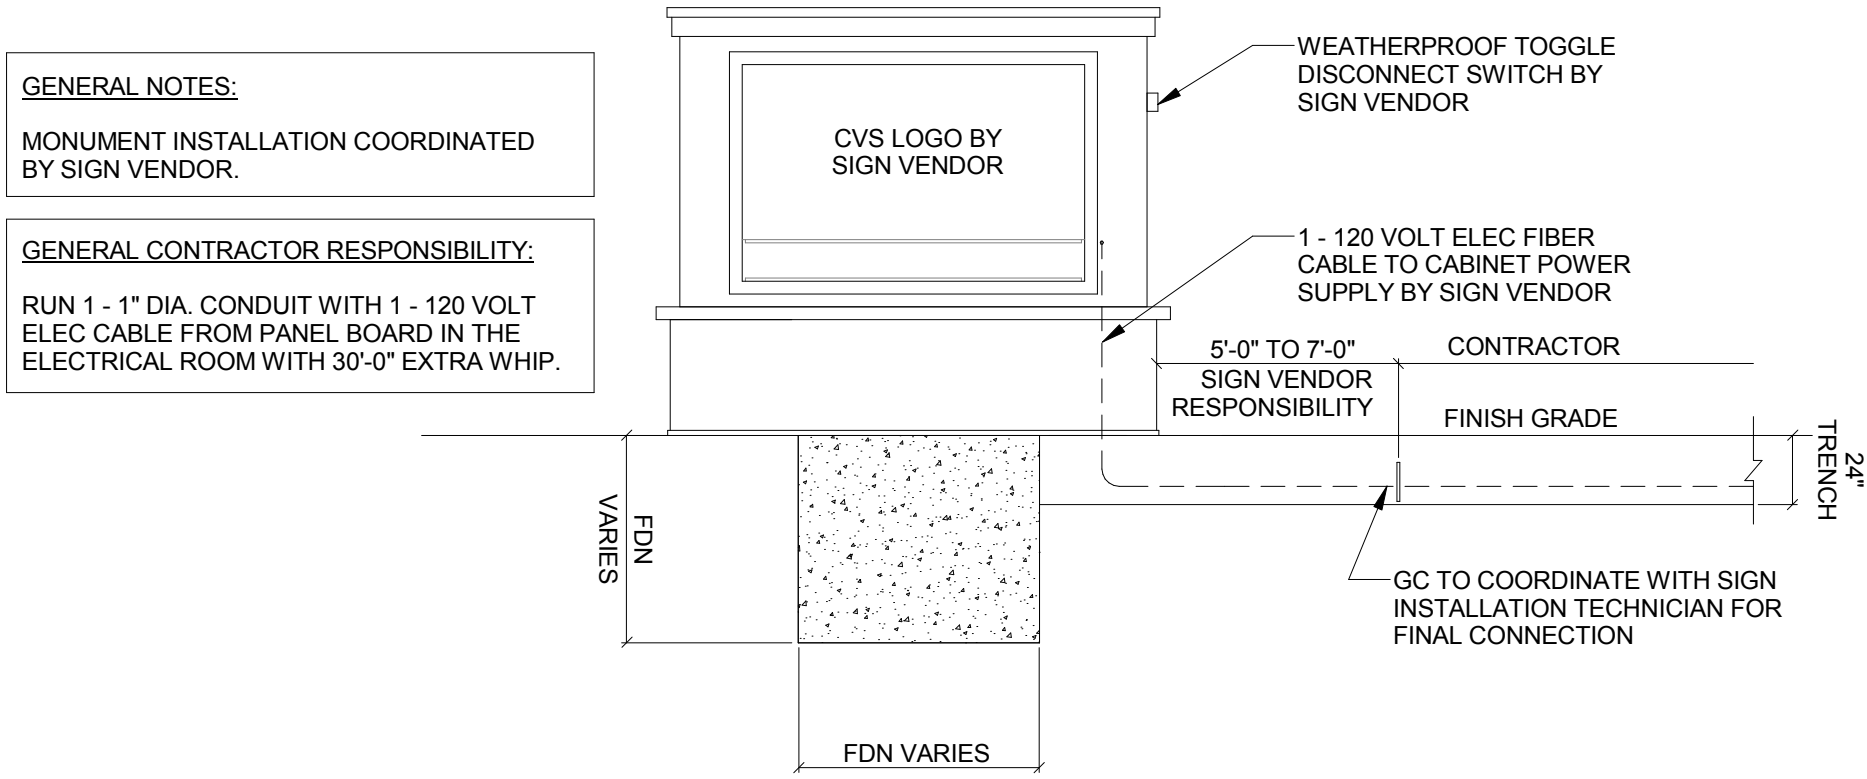

2 MONUMENT SIGN
1" = 20'-0"

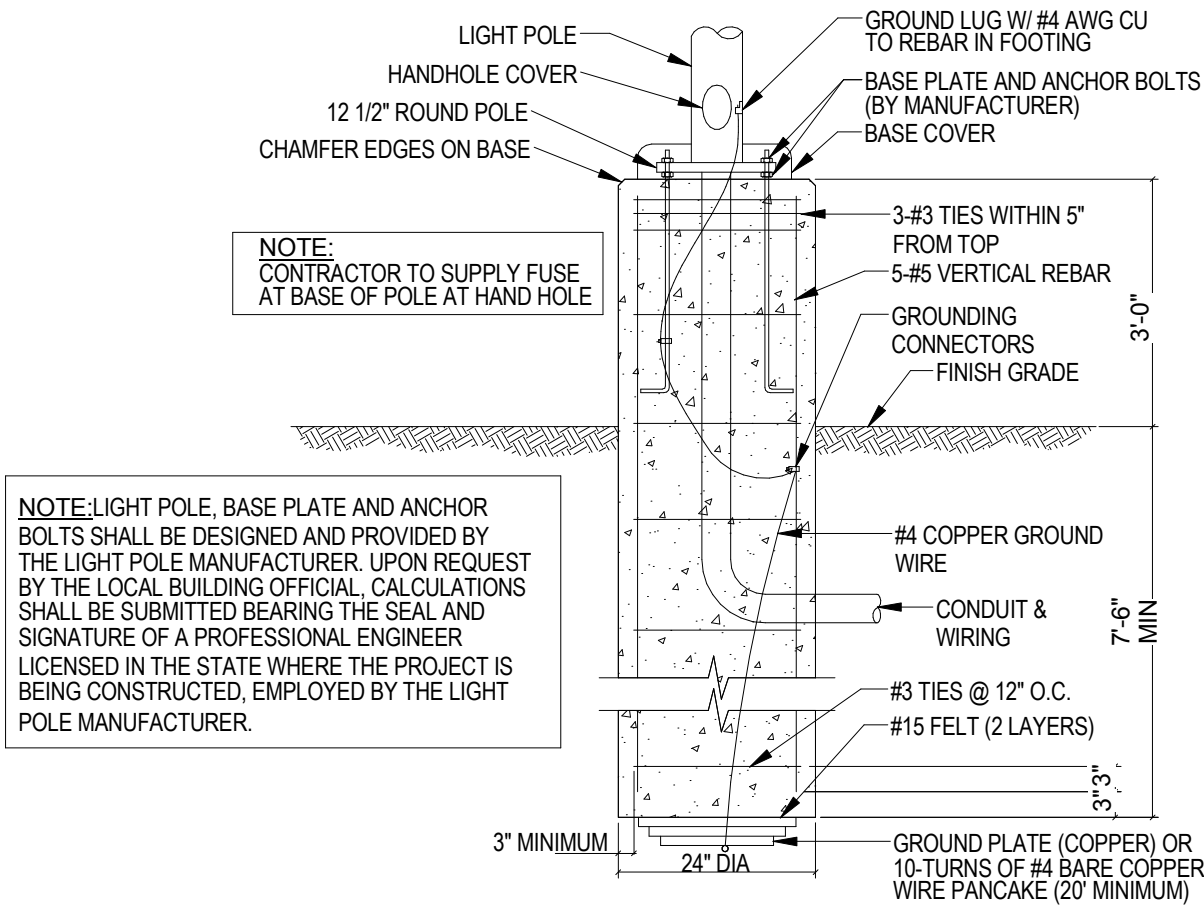

3 SITE LIGHTING BASE DETAIL
NTS

(X) ELECTRICAL LEGEND NOTES (SHEET ES1 ONLY)

1. DISCONNECT SWITCH PROVIDED WITH MONUMENT/PYLON SIGN. VERIFY EXACT LOCATIONS OF SIGNS WITH SIGN VENDOR PRIOR TO ANY WORK.
2. PROVIDE 2#6 & #6G - 1" THROUGHOUT CIRCUIT.
3. PROVIDE 2#6 & 1#6S - 1" THROUGHOUT CIRCUIT.
4. COORDINATE ALL EXTERIOR WALL PACK LIGHT FIXTURE LOCATIONS WITH SHEET A4 AND SHEET E2 FOR CIRCUIT INFORMATION.
5. PROVIDE 30A/3P/30AF/3R DISCONNECT SWITCH MOUNT AT 44" AFF. CONNECT TO DEDICATED 30A-3P CIRCUIT BREAKER WITH 3#10 & 1#10 - 3/4" THROUGHOUT CIRCUIT FOR REMOTE VERTICAL TRASH COMPACTOR. COORDINATE LOCATION OF DISCONNECT SWITCH WITH ARCHITECT PRIOR TO ROUGH-IN.
6. COORDINATE LOCATION OF UTILITY TRANSFORMER WITH CIVIL PLANS. COORDINATE REQUIREMENTS. PROVIDE MATERIALS AND PERFORM WORKS AS REQUIRED BY UTILITY COMPANY.
7. ELECTRICAL SERVICE ENTRANCE LOCATION. RE: E3



9k_CR
CENTER ENTRY
RIGHT BUMPOUT DRIVE-THRU
STORE NUMBER: 11162
VALWOOD PKWY & JOSEY LN
FARMERS BRANCH, TEXAS 75234
PROJECT TYPE: NEW STORE
DEAL TYPE: FFS
CS PROJECT NUMBER: 100204

ARCHITECT OF RECORD:
GENESIS DESIGN GROUP, INC.
421 W. HARWOOD ROAD
SUITE 100
HURST, TX 76054
TEL (817) 285-7444
FAX (817) 285-7318
TX FIRM #BR-2139

STRUCTURAL ENGINEER:
HUNT & JOINER, INC.
1825 MARKET CENTER BLVD.
STE 620
DALLAS, TX 75207
TEL (214) 760-7000
FAX (214) 760-7050
TX REG# 2423 PROJECT NO. 17110

MEP ENGINEER:
DON PENN CONSULTING ENGINEER
TEXAS REGD ENGINEERING FIRM F-2245
1301 SOLANA BLVD.
BLDG 1, STE 1420
WESKLAKE, TX 76262
TEL (817) 410-2858
FAX (817) 251-8411

DEVELOPER:
ORANGE DEVELOPMENT
1200 CORPORATE DRIVE
SUITE G-50
BIRMINGHAM, AL 35242
TEL (205) 408-3443



REVISIONS	

DRAWING BY: VO
DATE: 07-13-2017
JOB NUMBER: 17-016
TITLE:

ELECTRICAL SITE PLAN
SHEET NUMBER: ES1
COMMENTS:
ISSUED FOR CONSTRUCTION